














LIFE SAFETY PLAN KEY















 
AREAS


-  SPRINKLED AREA
-  HAZARDOUS AREA
-  AREA PROTECTED BY FIRE DETECTION SYSTEM
-  EXIT STAIR

BARRIERS

-  1 HOUR FIRE RATED BARRIER
-  2 HOUR FIRE RATED BARRIER
-  3 HOUR RATED FIRE BARRIER
-  NON-RATED SMOKE LIMITING BARRIER (CORRIDOR WALL)
-  NON-RATED SMOKE BARRIER
-  COMBINATION 1/2 HOUR RATED FIRE BARRIER & SMOKE BARRIER
-  COMBINATION 1 HOUR RATED FIRE BARRIER & SMOKE BARRIER
-  COMBINATION 2 HOUR RATED FIRE BARRIER & SMOKE BARRIER
-  COMBINATION 3 HOUR RATED FIRE BARRIER & SMOKE BARRIER

SYMBOLS


-  PATH OF MEANS OF EGRESS
-  EXIT DISCHARGE
-  EXIT SIGN
-  FIRE EXTINGUISHER
-  PULL STATION
-  DETECTOR
-  ALARM/STROBE
-  FIRE ALARM HORN
-  EMERGENCY LIGHT
-  FIRE ALARM CONTROL PANEL
-  FIRE ALARM ANNUNCIATOR PANEL
-  ELECTRICAL PANEL
-  SPRINKLER SHUTOFF VALVE
-  KITCHEN HOOD SUPPRESSION SYSTEM
-  KITCHEN SYSTEM PULL STATION

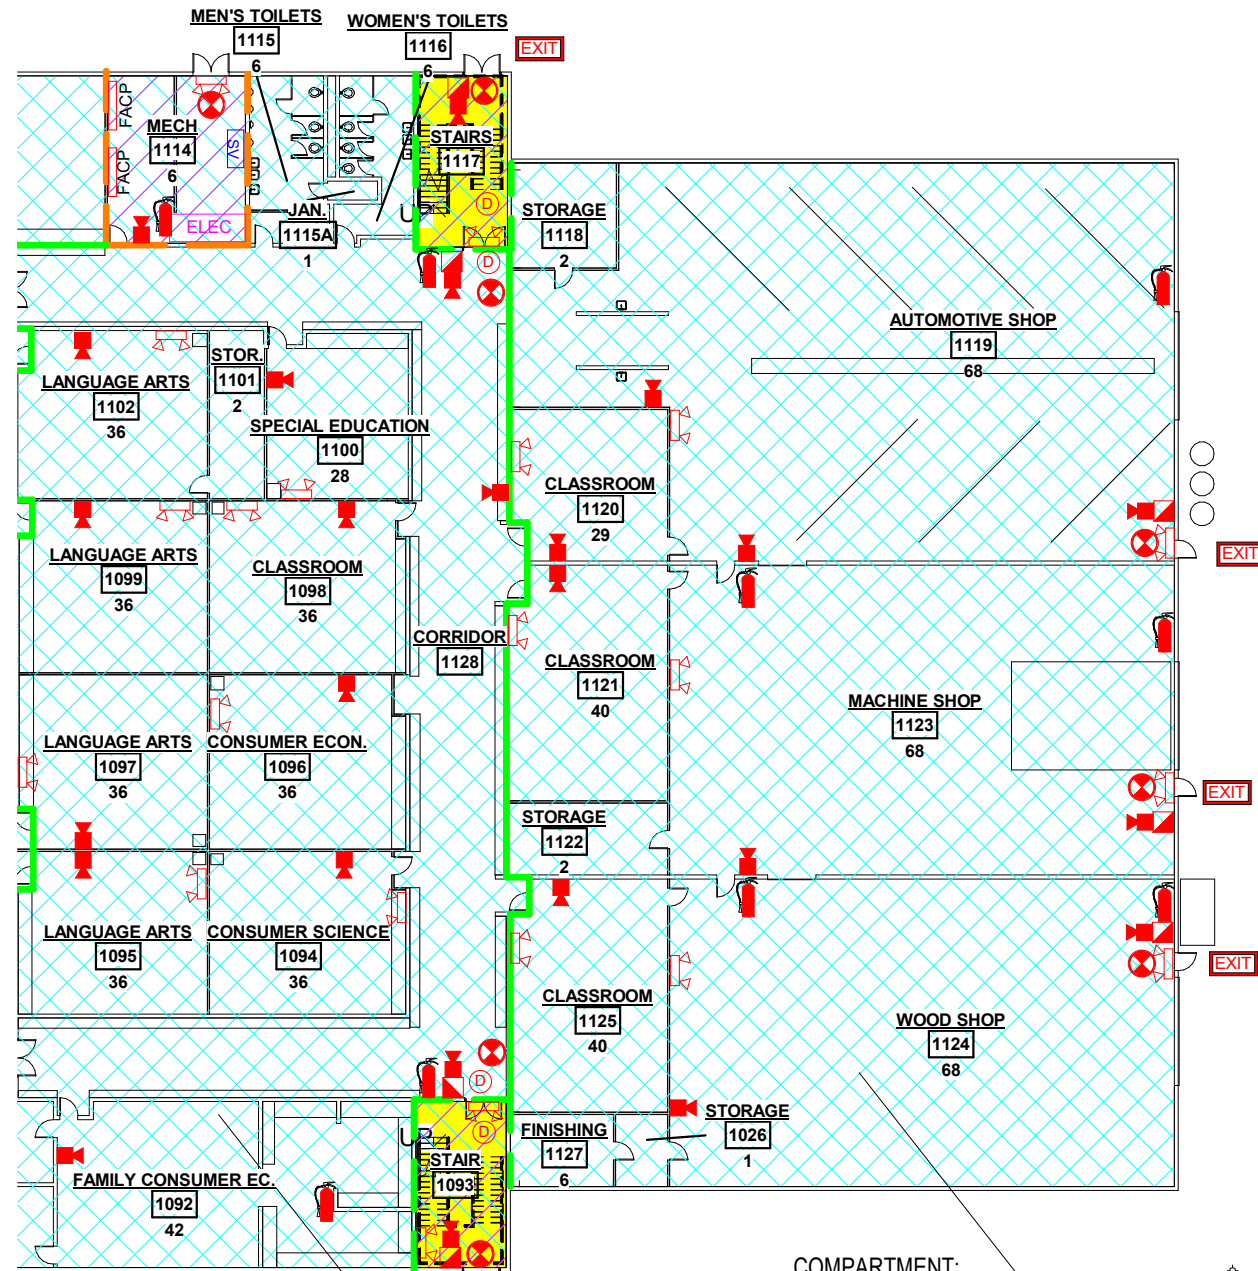

COMPARTMENT:
SECTION #1
CONST. 2002
CONS. TYPE II
52,330 S.F.
CODE BOCA 96:

COMPARTMENT:
SECTION #2
CONST. 2002
CONS. TYPE II
15,200 S.F.
CODE BOCA 96:

② SECTION #2 FLOOR PLAN
1/32" = 1'-0"

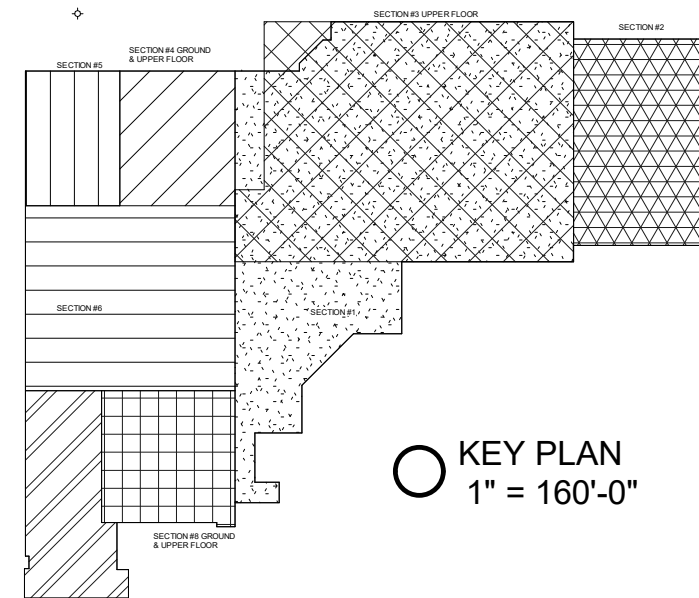

○ KEY PLAN
1" = 160'-0"

PARTIAL FLOOR PLAN





HERRIN CUSD #4

LS-1.0		Scale As indicated
Project number	19-985	
Date	12-6-19	
Drawn by	CLO	
Checked by	SBS	










10 YEAR HEALTH LIFE SAFETY

LIFE SAFETY PLAN KEY













 


AREAS


-  SPRINKLED AREA
-  HAZARDOUS AREA
-  AREA PROTECTED BY FIRE DETECTION SYSTEM
-  EXIT STAIR

BARRIERS

-  1 HOUR FIRE RATED BARRIER
-  2 HOUR FIRE RATED BARRIER
-  3 HOUR RATED FIRE BARRIER
-  NON-RATED SMOKE LIMITING BARRIER (CORRIDOR WALL)
-  NON-RATED SMOKE BARRIER
-  COMBINATION 1/2 HOUR RATED FIRE BARRIER & SMOKE BARRIER
-  COMBINATION 1 HOUR RATED FIRE BARRIER & SMOKE BARRIER
-  COMBINATION 2 HOUR RATED FIRE BARRIER & SMOKE BARRIER
-  COMBINATION 3 HOUR RATED FIRE BARRIER & SMOKE BARRIER


SYMBOLS

-  PATH OF MEANS OF EGRESS
-  EXIT DISCHARGE
-  EXIT SIGN
-  FIRE EXTINGUISHER
-  PULL STATION
-  DETECTOR
-  ALARM/STROBE
-  FIRE ALARM HORN
-  EMERGENCY LIGHT
-  FIRE ALARM CONTROL PANEL
-  FIRE ALARM ANNUNCIATOR PANEL
-  ELECTRICAL PANEL
-  SPRINKLER SHUTOFF VALVE
-  KITCHEN HOOD SUPPRESSION SYSTEM
-  KITCHEN SYSTEM PULL STATION

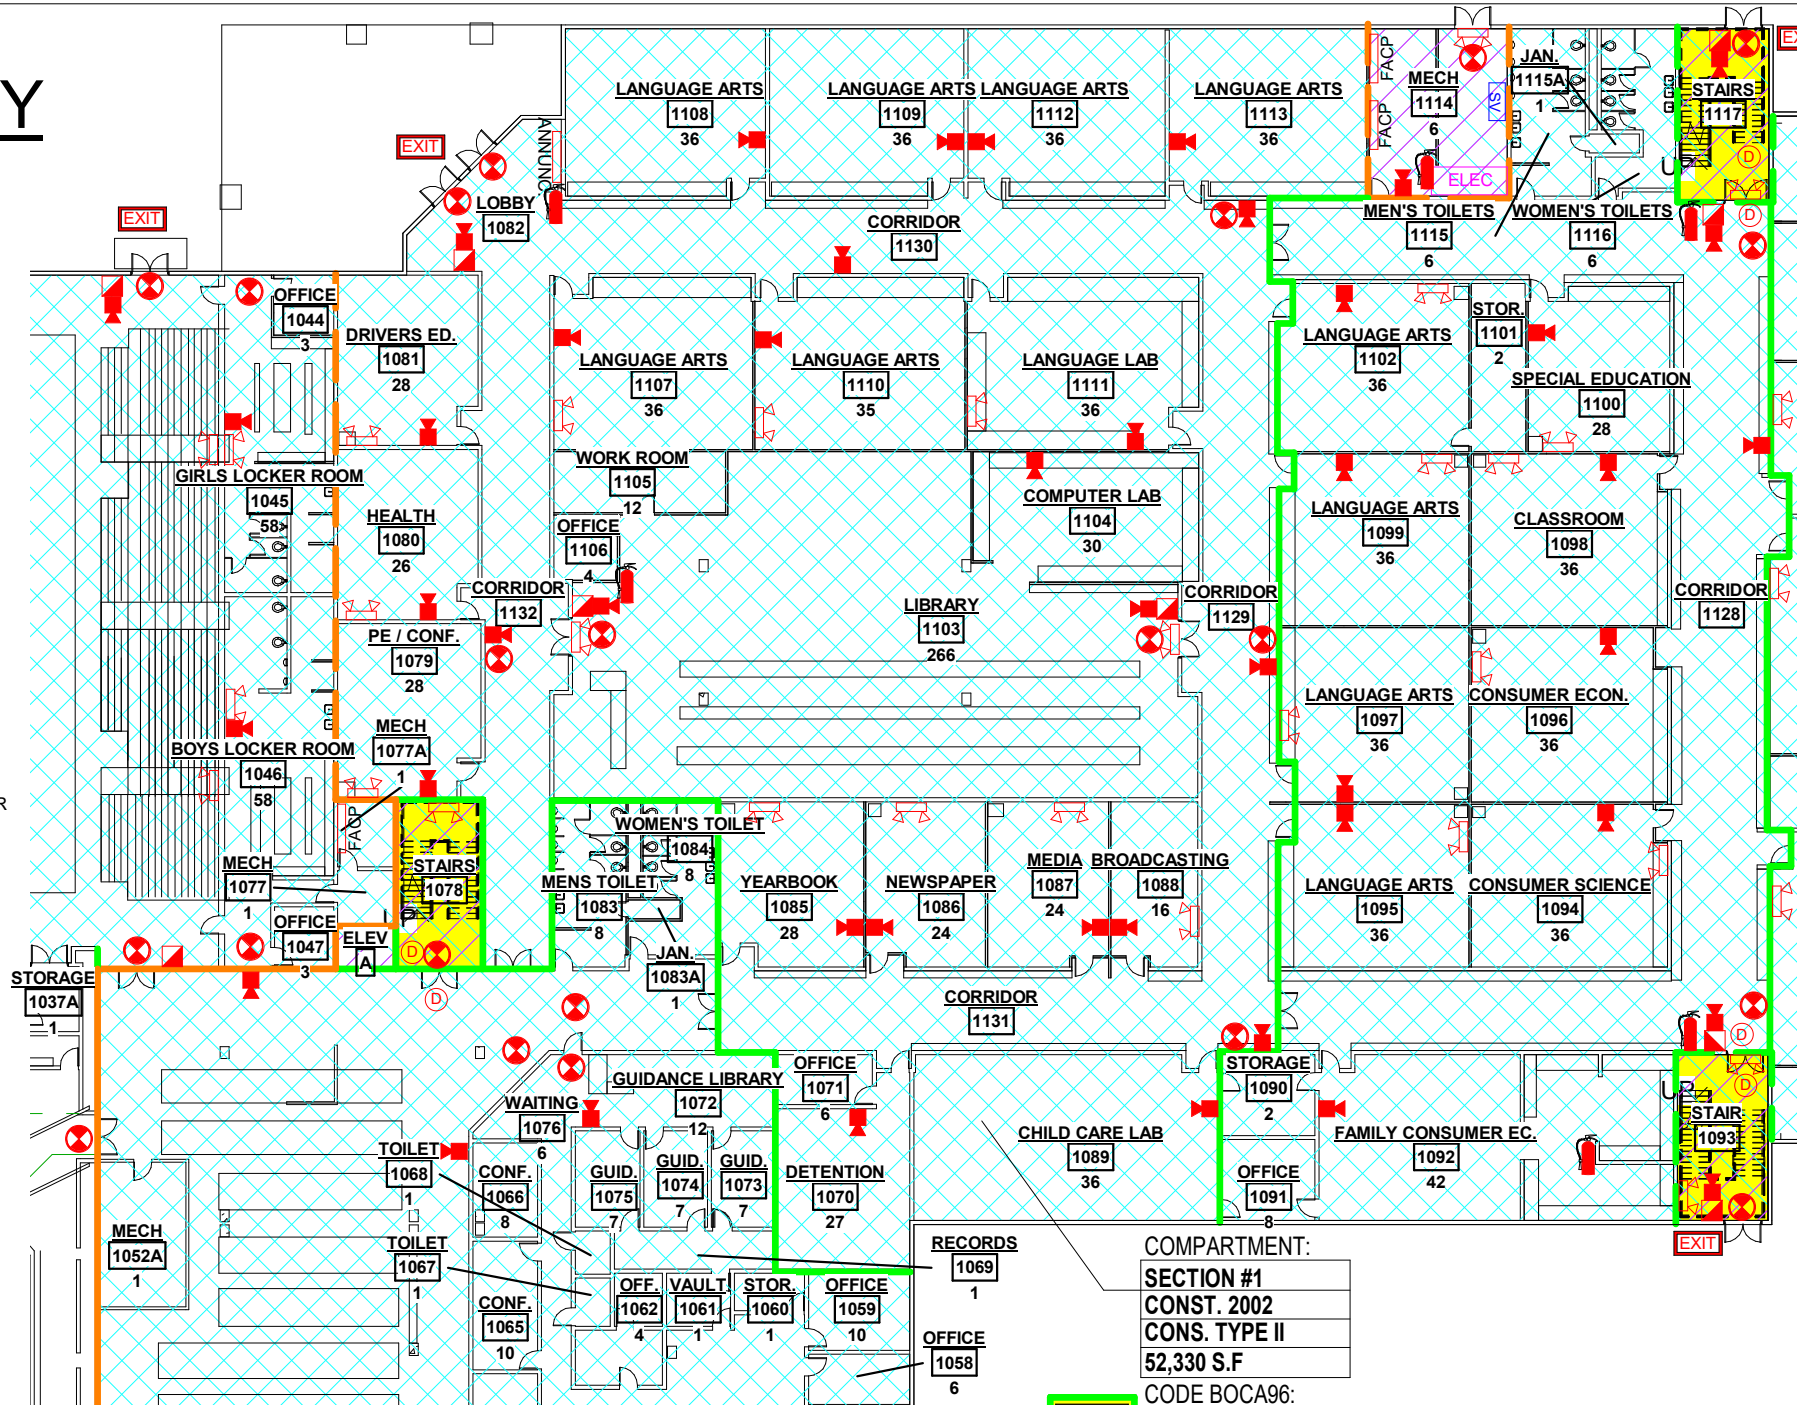

① SECTION #1 FLOOR PLAN - NORTH
1/32" = 1'-0"

② BASEMENT PLAN
1/32" = 1'-0"

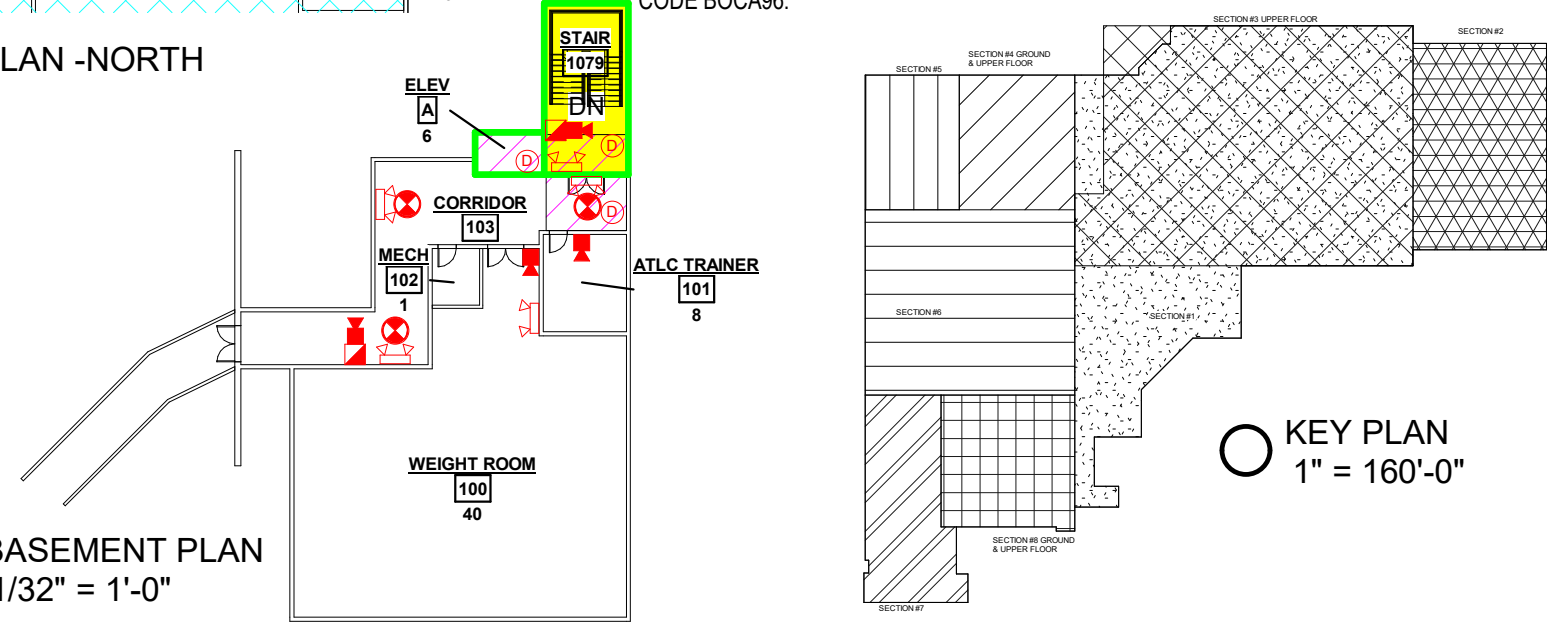

○ KEY PLAN
1" = 160'-0"

PARTIAL FLOOR PLAN

HERRIN CUSD #4

Project number	19-985
Date	12-6-19
Drawn by	CLO
Checked by	SBS

10 YEAR HEALTH LIFE SAFETY





ARCHITECTURALS LIMITED
 817 SOUTH PARK AVENUE
 HERRIN, ILLINOIS 62946
 phone: 618-942-6918 fax: 618-942-6919
 email: general@architecturals.com

LS-1.1










Scale As indicated

LIFE SAFETY PLAN KEY











 




AREAS


-  SPRINKLED AREA
-  HAZARDOUS AREA
-  AREA PROTECTED BY FIRE DETECTION SYSTEM
-  EXIT STAIR

BARRIERS

-  1 HOUR FIRE RATED BARRIER
-  2 HOUR FIRE RATED BARRIER
-  3 HOUR RATED FIRE BARRIER
-  NON-RATED SMOKE LIMITING BARRIER (CORRIDOR WALL)
-  NON-RATED SMOKE BARRIER
-  COMBINATION 1/2 HOUR RATED FIRE BARRIER & SMOKE BARRIER
-  COMBINATION 1 HOUR RATED FIRE BARRIER & SMOKE BARRIER
-  COMBINATION 2 HOUR RATED FIRE BARRIER & SMOKE BARRIER
-  COMBINATION 3 HOUR RATED FIRE BARRIER & SMOKE BARRIER

SYMBOLS

-  PATH OF MEANS OF EGRESS
-  EXIT DISCHARGE
-  EXIT SIGN
-  FIRE EXTINGUISHER
-  PULL STATION
-  DETECTOR
-  ALARM/STROBE
-  FIRE ALARM HORN
-  EMERGENCY LIGHT
-  FIRE ALARM CONTROL PANEL
-  FIRE ALARM ANNUNCIATOR PANEL
-  ELECTRICAL PANEL
-  SPRINKLER SHUTOFF VALVE
-  KITCHEN HOOD SUPPRESSION SYSTEM
-  KITCHEN SYSTEM PULL STATION

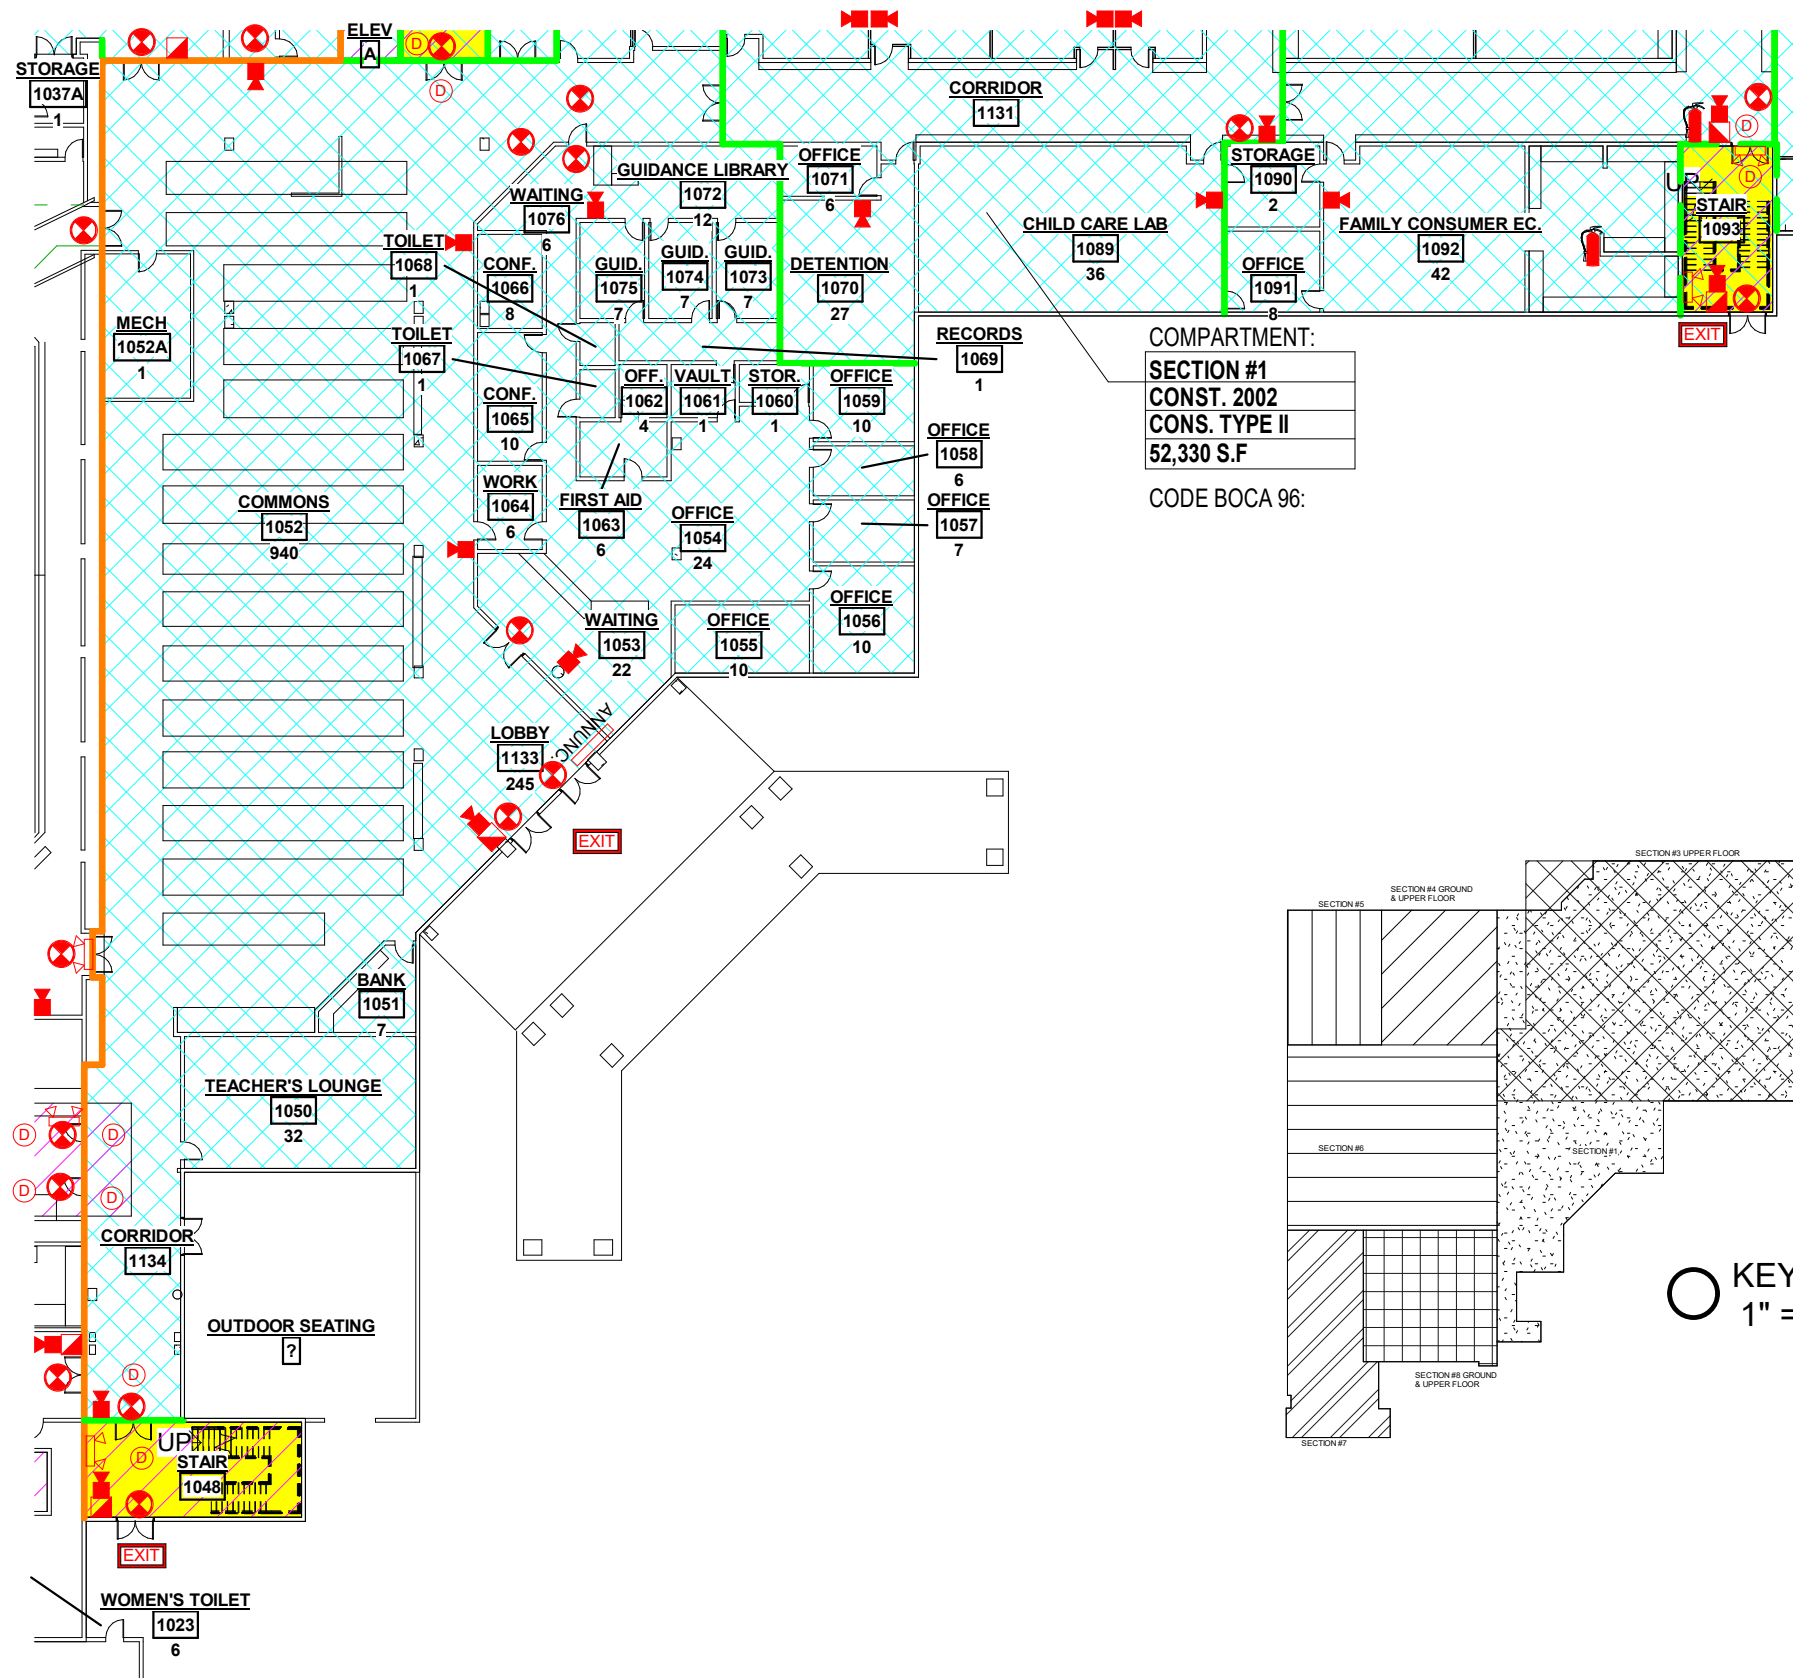

COMPARTMENT:
 SECTION #1
 CONST. 2002
 CONS. TYPE II
 52,330 S.F
 CODE BOCA 96:

 **SECTION #1 FLOOR PLAN -SOUTH**
 PLAN NORTH SCALE: 1/32" = 1'-0"

PARTIAL FLOOR PLAN

Project number 19-985
 Date 12-6-19
 Drawn by CLO
 Checked by SBS

LS-1.2

Scale As indicated





HERRIN CUSD #4

10 YEAR HEALTH LIFE SAFETY










ARCHITECHNIQUES
 LIMITED
 817 SOUTH PARK AVENUE
 HERRIN, ILLINOIS 62946
 phone: 618-942-6818 fax: 618-942-6819
 email: general@architechniquesllc.com

LIFE SAFETY PLAN KEY
















AREAS


-  SPRINKLED AREA
-  HAZARDOUS AREA
-  AREA PROTECTED BY FIRE DETECTION SYSTEM
-  EXIT STAIR

BARRIERS

-  1 HOUR FIRE RATED BARRIER
-  2 HOUR FIRE RATED BARRIER
-  3 HOUR RATED FIRE BARRIER
-  NON-RATED SMOKE LIMITING BARRIER (CORRIDOR WALL)
-  NON-RATED SMOKE BARRIER
-  COMBINATION 1/2 HOUR RATED FIRE BARRIER & SMOKE BARRIER
-  COMBINATION 1 HOUR RATED FIRE BARRIER & SMOKE BARRIER
-  COMBINATION 2 HOUR RATED FIRE BARRIER & SMOKE BARRIER
-  COMBINATION 3 HOUR RATED FIRE BARRIER & SMOKE BARRIER

SYMBOLS


-  PATH OF MEANS OF EGRESS
-  EXIT DISCHARGE
-  EXIT SIGN
-  FIRE EXTINGUISHER
-  PULL STATION
-  DETECTOR
-  ALARM/STROBE
-  FIRE ALARM HORN
-  EMERGENCY LIGHT
-  FIRE ALARM CONTROL PANEL
-  FIRE ALARM ANNUNCIATOR PANEL
-  ELECTRICAL PANEL
-  SPRINKLER SHUTOFF VALVE
-  KITCHEN HOOD SUPPRESSION SYSTEM
-  KITCHEN SYSTEM PULL STATION

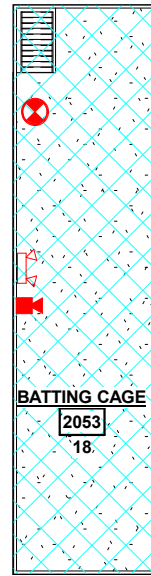



② SECTION #4 UPPER LEVEL PLAN
1/32" = 1'-0"

COMPARTMENT:
SECTION #5
CONST. 2002
CONS. TYPE II
7,488 S.F.
CODE BOCA 96:

COMPARTMENT:
SECTION #4
CONST. 2002
CONS. TYPE II
11,024 S.F.
CODE BOCA 96:

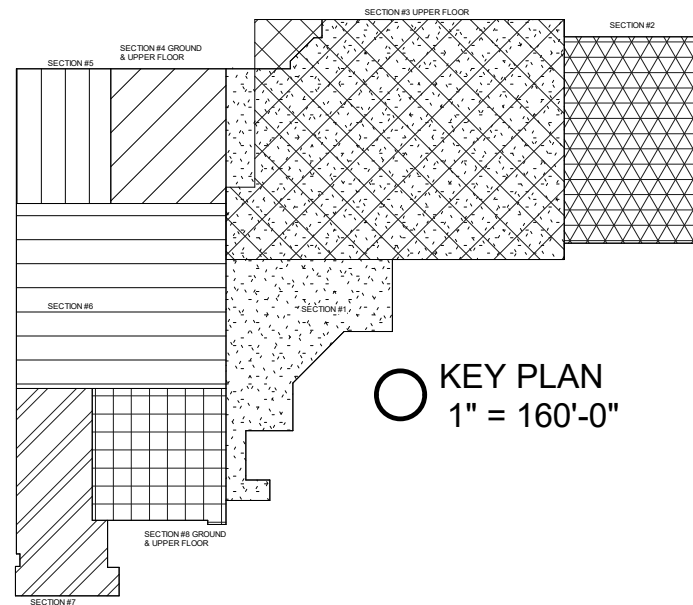

○ KEY PLAN
1" = 160'-0"

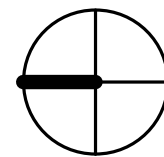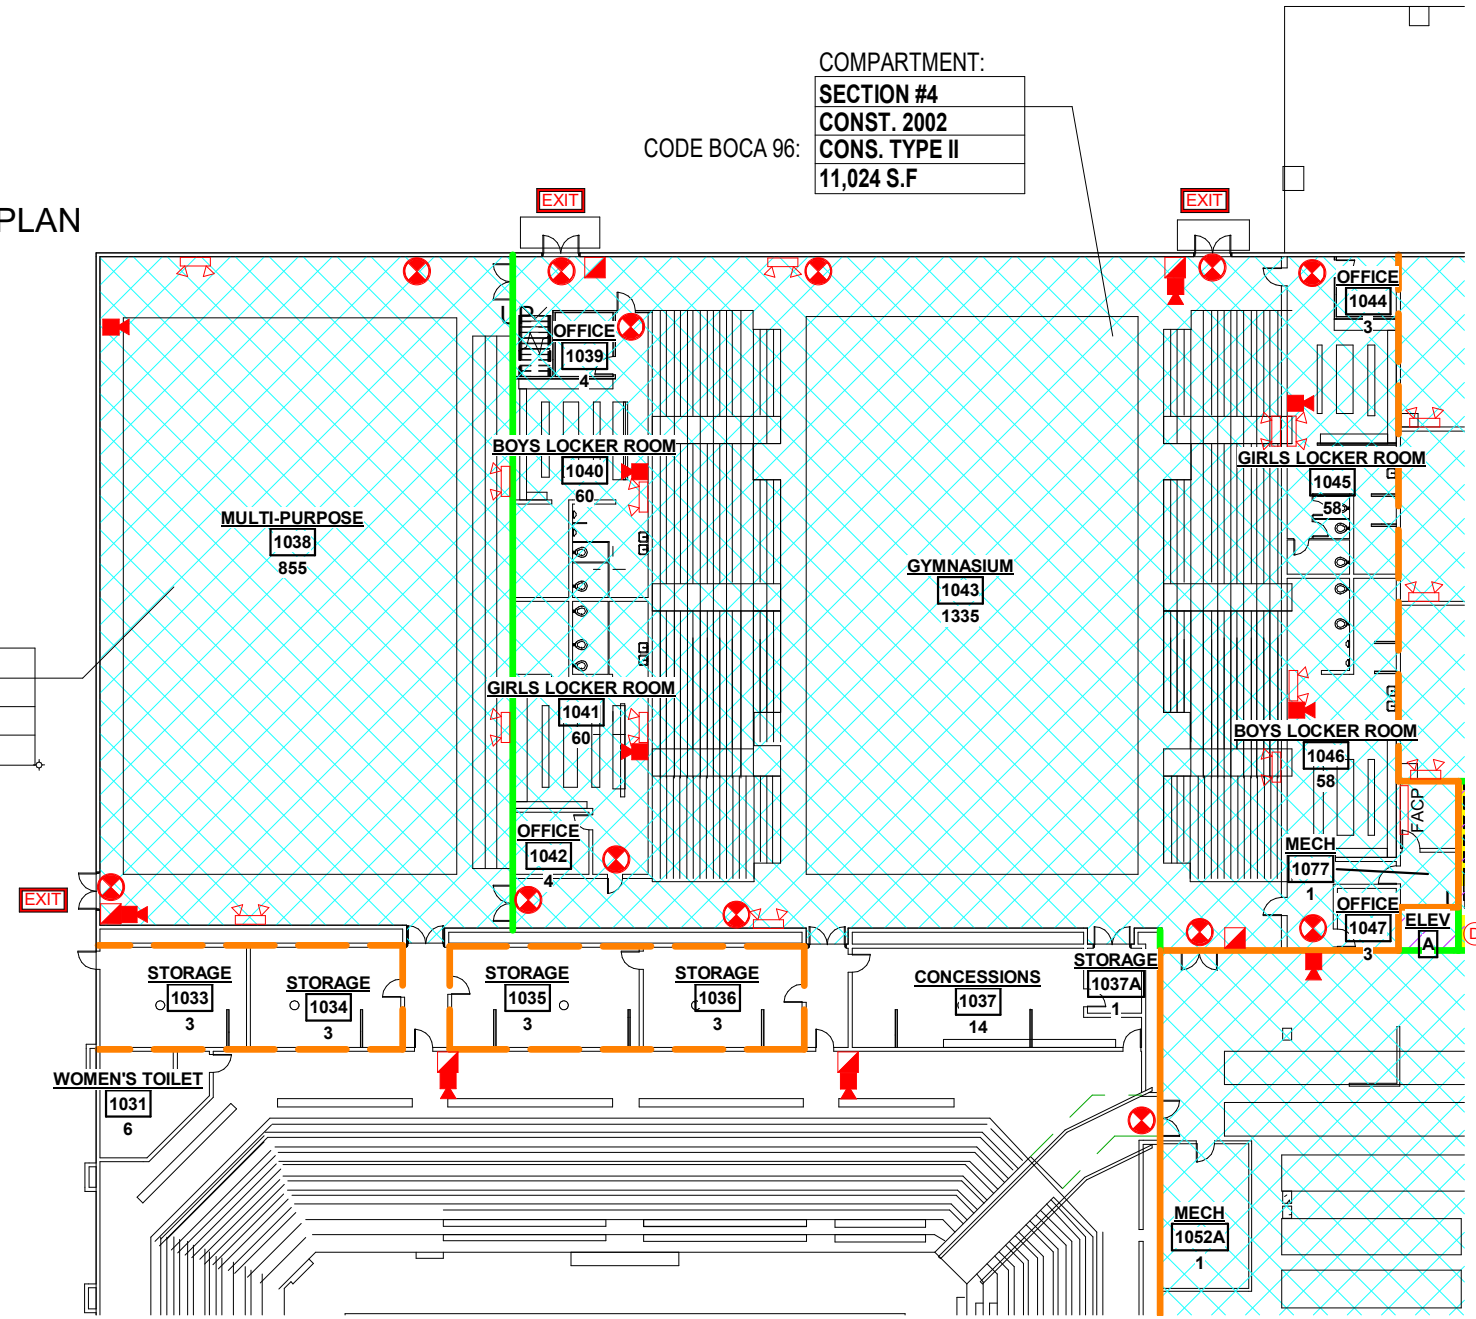

SECTION #4 & #5 FLOOR PLAN

PLAN NORTH

SCALE: 1/32" = 1'-0"

PARTIAL FLOOR PLAN

HERRIN CUSD #4

LS-1.3

Scale As indicated

Project number 19-985

Date 12-6-19

Drawn by CLO

Checked by SBS

 



10 YEAR HEALTH LIFE SAFETY

817 SOUTH PARK AVENUE
HERRIN, ILLINOIS 62946
phone: 618-942-6818 fax: 618-942-6819
email: general@architechniquesllc.com












LIFE SAFETY PLAN KEY

AREAS










 





-  SPRINKLED AREA
-  HAZARDOUS AREA
-  AREA PROTECTED BY FIRE DETECTION SYSTEM
-  EXIT STAIR

COMPARTMENT:
SECTION #6
 CONST. 1950
 CONS. TYPE II
 22,508 S.F.
 CODE 185:

BARRIERS


-  1 HOUR FIRE RATED BARRIER
-  2 HOUR FIRE RATED BARRIER
-  3 HOUR RATED FIRE BARRIER
-  NON-RATED SMOKE LIMITING BARRIER (CORRIDOR WALL)
-  NON-RATED SMOKE BARRIER
-  COMBINATION 1/2 HOUR RATED FIRE BARRIER & SMOKE BARRIER
-  COMBINATION 1 HOUR RATED FIRE BARRIER & SMOKE BARRIER
-  COMBINATION 2 HOUR RATED FIRE BARRIER & SMOKE BARRIER
-  COMBINATION 3 HOUR RATED FIRE BARRIER & SMOKE BARRIER

SYMBOLS


-  PATH OF MEANS OF EGRESS
-  EXIT DISCHARGE
-  EXIT SIGN
-  FIRE EXTINGUISHER
-  PULL STATION
-  DETECTOR
-  ALARM/STROBE
-  FIRE ALARM HORN
-  EMERGENCY LIGHT
-  FIRE ALARM CONTROL PANEL
-  FIRE ALARM ANNUNCIATOR PANEL
-  ELECTRICAL PANEL
-  SPRINKLER SHUTOFF VALVE
-  KITCHEN HOOD SUPPRESSION SYSTEM
-  KITCHEN SYSTEM PULL STATION

COMPARTMENT:
SECTION #7
 CONST. 1950
 CONS. TYPE II
 19,390 S.F.
 CODE 185:


COMPARTMENT:
SECTION #8
 CONST. 1965
 CONS. TYPE II
 7,948 S.F.
 CODE 175:

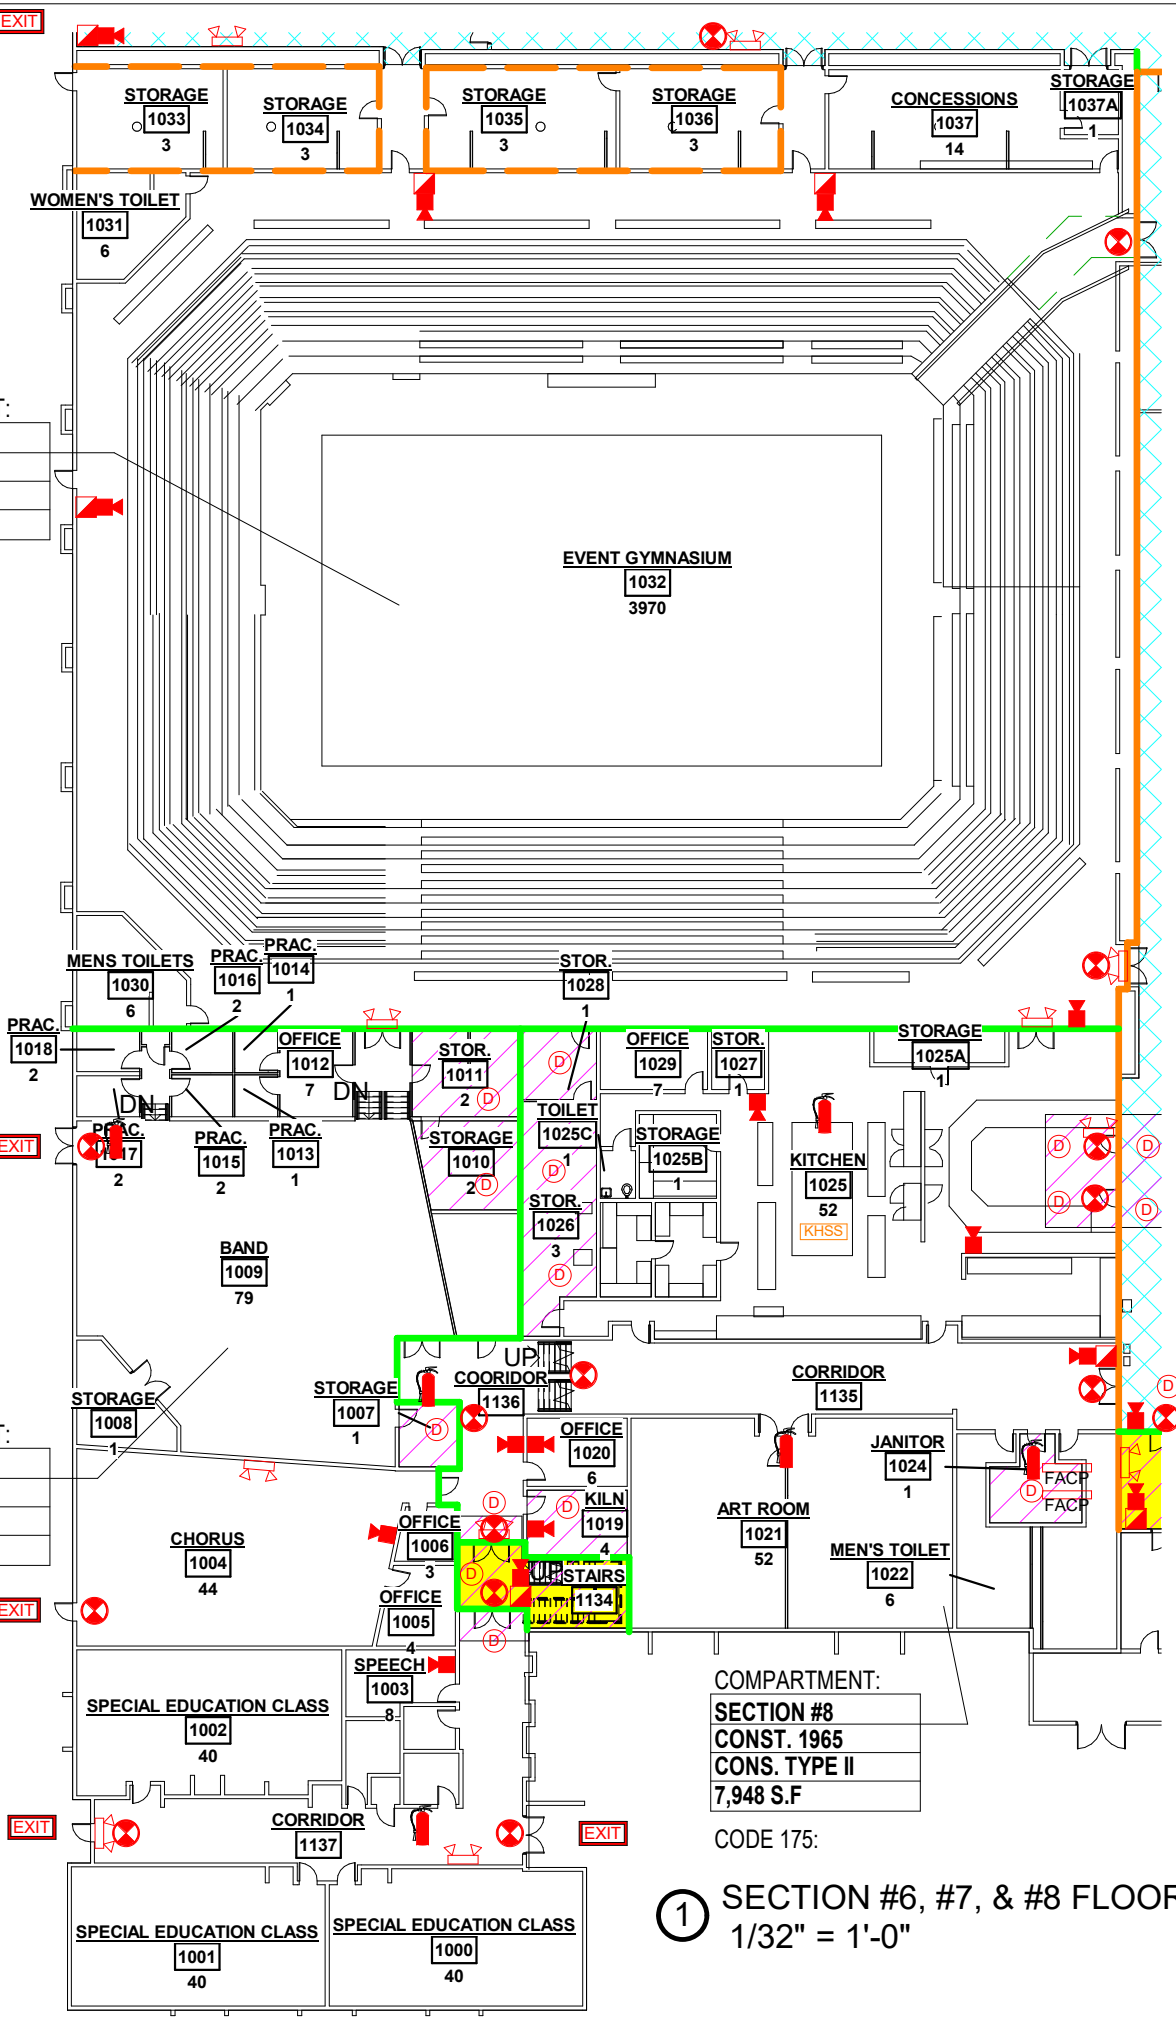

① SECTION #6, #7, & #8 FLOOR PLAN
 1/32" = 1'-0"

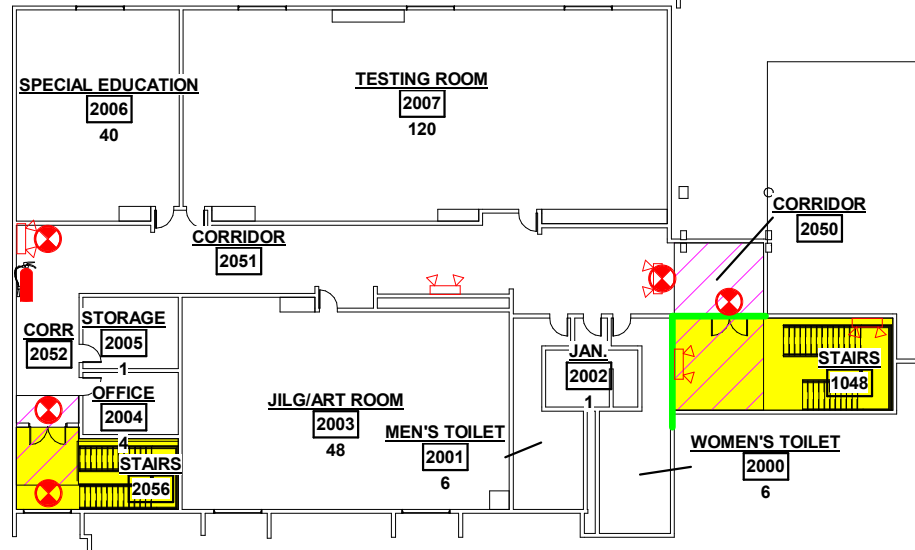

② SECTION #8 UPPER LEVEL PLAN
 1/32" = 1'-0"

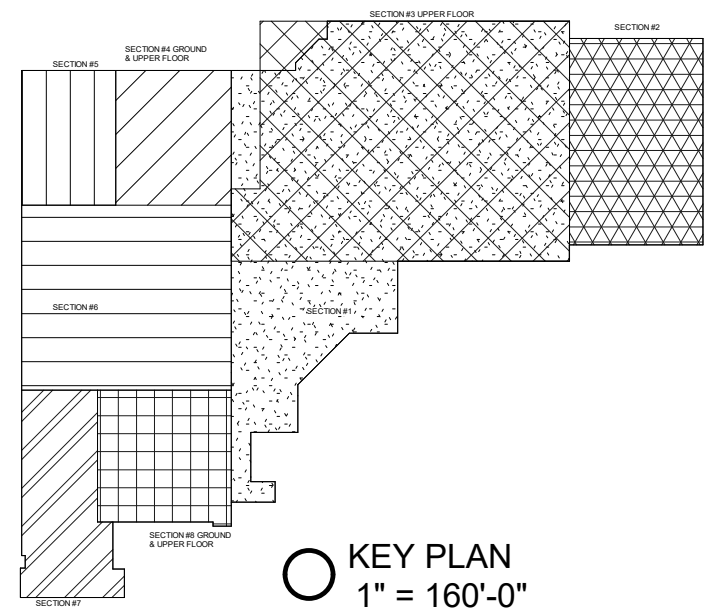

○ KEY PLAN
 1" = 160'-0"

PARTIAL FLOOR PLAN





HERRIN CUSD #4

LS-1.4		Scale As indicated
Project number	19-985	
Date	12-6-19	
Drawn by	CLO	
Checked by	SBS	










10 YEAR HEALTH LIFE SAFETY

LIFE SAFETY PLAN KEY














 

AREAS


-  SPRINKLED AREA
-  HAZARDOUS AREA
-  AREA PROTECTED BY FIRE DETECTION SYSTEM
-  EXIT STAIR

BARRIERS


-  1 HOUR FIRE RATED BARRIER
-  2 HOUR FIRE RATED BARRIER
-  3 HOUR RATED FIRE BARRIER
-  NON-RATED SMOKE LIMITING BARRIER (CORRIDOR WALL)
-  NON-RATED SMOKE BARRIER
-  COMBINATION 1/2 HOUR RATED FIRE BARRIER & SMOKE BARRIER
-  COMBINATION 1 HOUR RATED FIRE BARRIER & SMOKE BARRIER
-  COMBINATION 2 HOUR RATED FIRE BARRIER & SMOKE BARRIER
-  COMBINATION 3 HOUR RATED FIRE BARRIER & SMOKE BARRIER

SYMBOLS

-  PATH OF MEANS OF EGRESS
-  EXIT DISCHARGE
-  EXIT SIGN
-  FIRE EXTINGUISHER
-  PULL STATION
-  DETECTOR
-  ALARM/STROBE
-  FIRE ALARM HORN
-  EMERGENCY LIGHT
-  FIRE ALARM CONTROL PANEL
-  FIRE ALARM ANNUNCIATOR PANEL
-  ELECTRICAL PANEL
-  SPRINKLER SHUTOFF VALVE
-  KITCHEN HOOD SUPPRESSION SYSTEM
-  KITCHEN SYSTEM PULL STATION

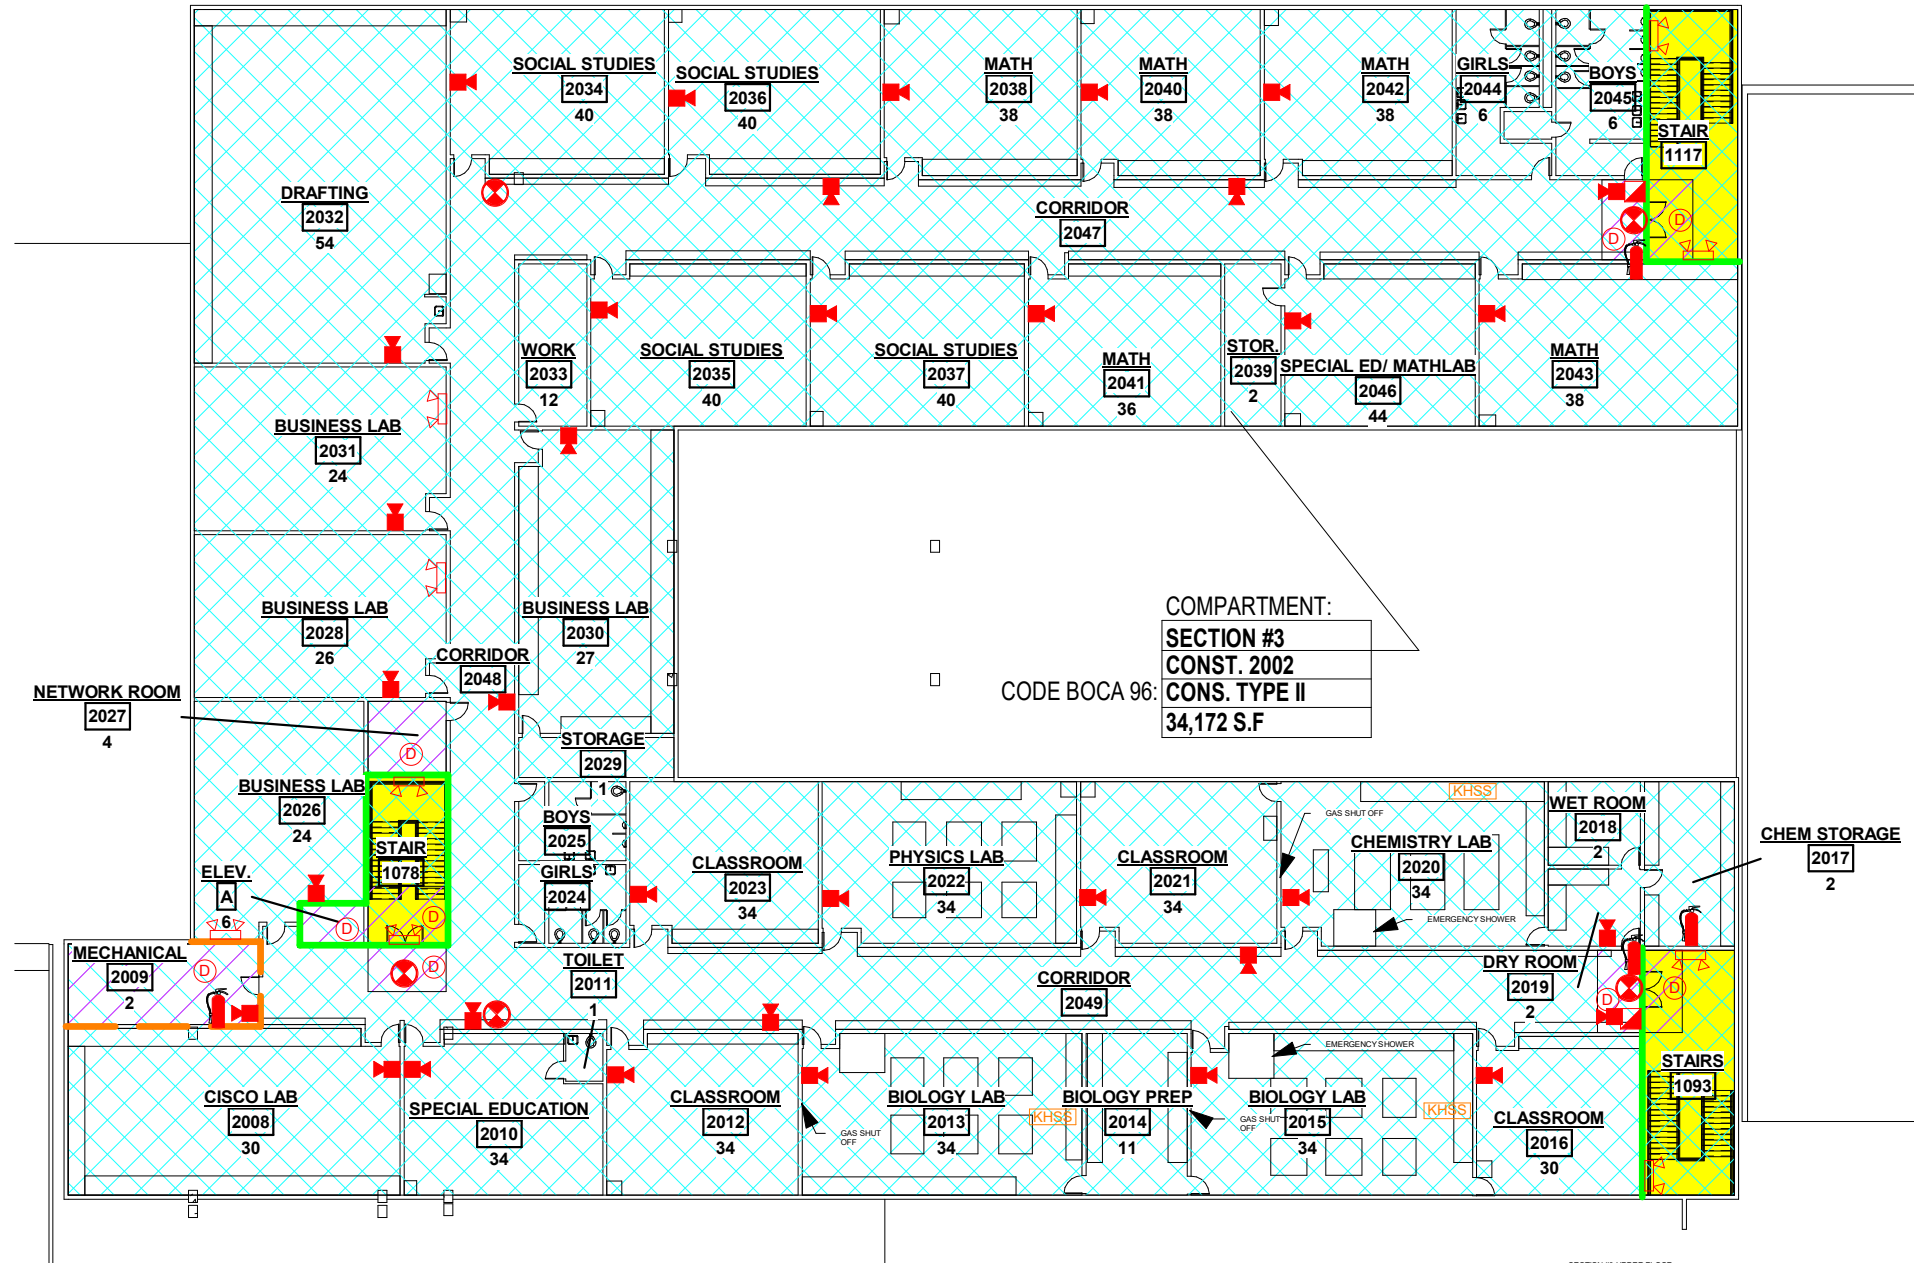

① SECTION #3 UPPER FLOOR PLAN
1/32" = 1'-0"

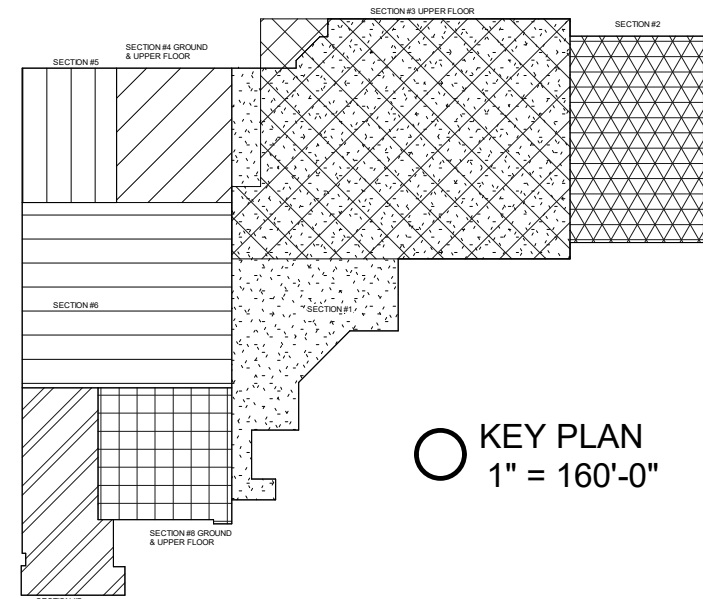

○ KEY PLAN
1" = 160'-0"

COMPARTMENT:
SECTION #3
CONST. 2002
CONS. TYPE II
34,172 S.F.

PARTIAL FLOOR PLAN

Project number 19-985
Date 12-6-19
Drawn by CLO
Checked by SBS

LS-1.5

Scale As indicated

HERRIN CUSD #4

10 YEAR HEALTH LIFE SAFETY


817 SOUTH PARK AVENUE
HERRIN, ILLINOIS 62946
phone: 618-942-6818 fax: 618-942-6819
email: general@architecturiques.com



HERRIN STREET

NORTH 11TH STREET

POLK STREET

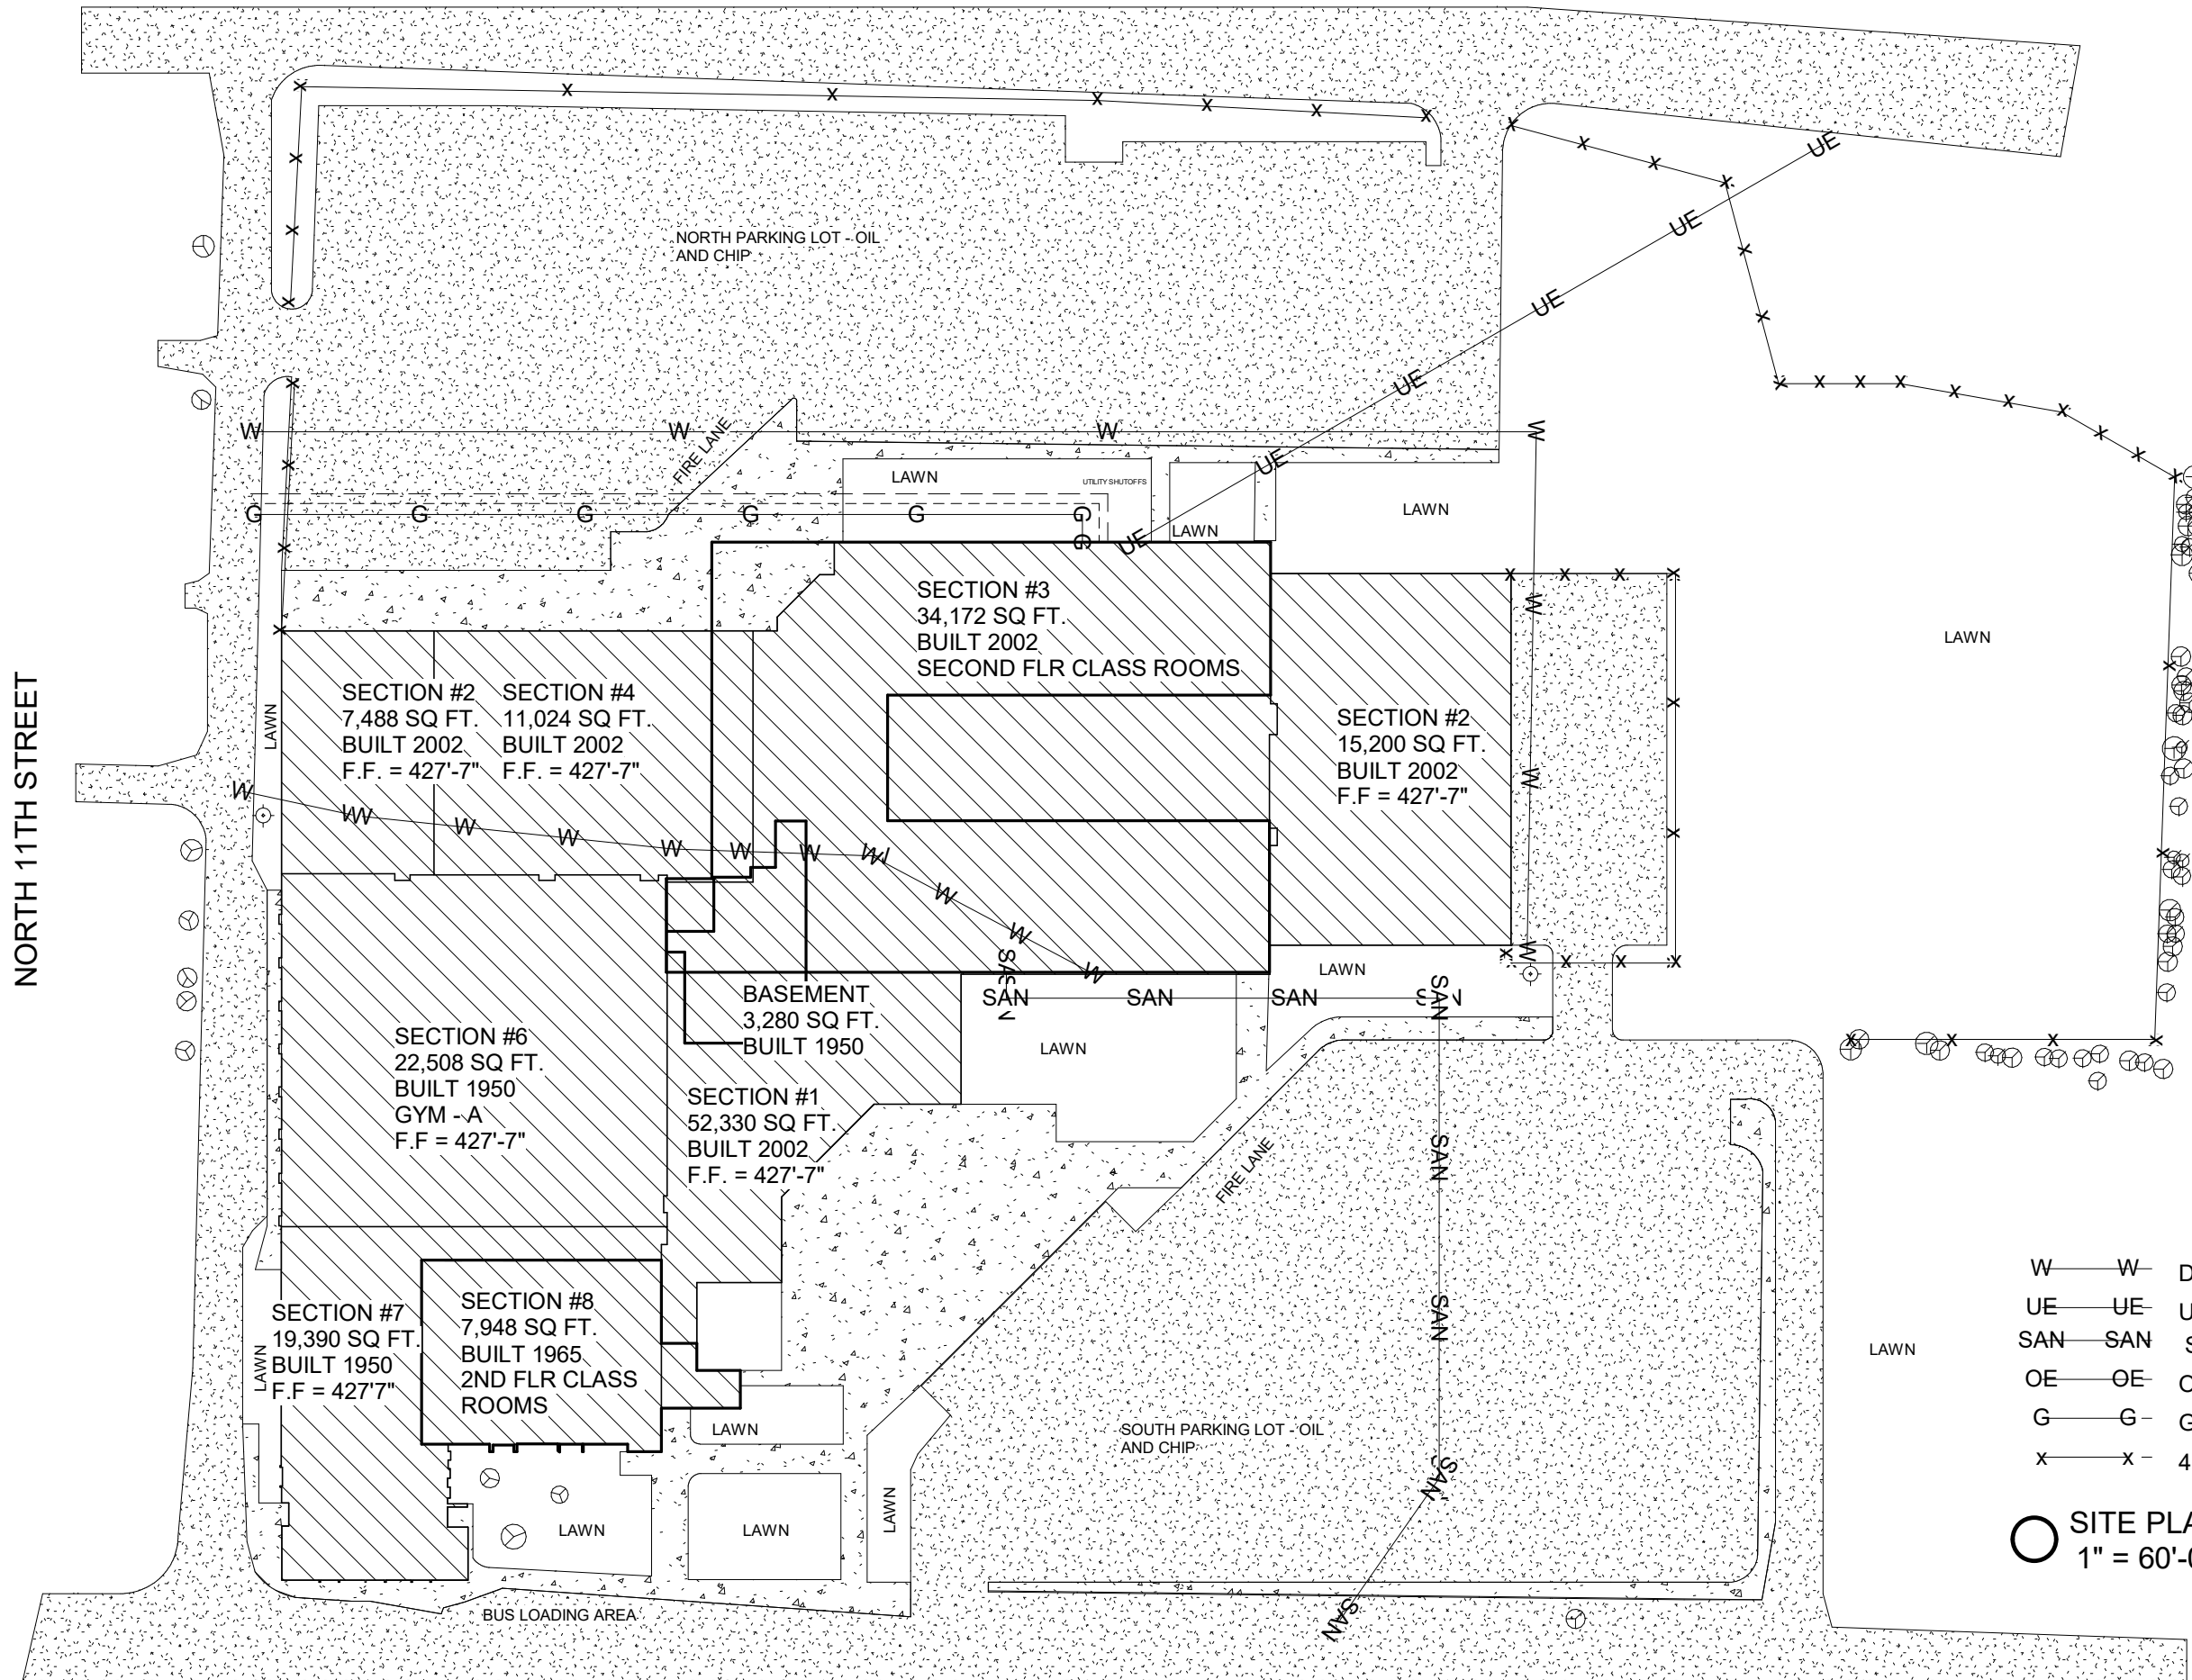

- W—W— DOMESTIC WATER LINE
- UE—UE— UNDERGROUND ELECTRICAL LINE
- SAN—SAN— SANITARY SEWER LINE
- OE—OE— OVERHEAD UTILITY LINE
- G—G— GAS LINE
- X—X— 4 FOOT HIGH CHAIN LINK FENCE

○ SITE PLAN LEGEND
1" = 60'-0"

① Site Plan
1" = 80'-0"

SITE PLAN

HERRIN CUSD #4

10 YEAR HEALTH LIFE SAFETY

ARCHITECTURALS
LIMITED

817 SOUTH PARK AVENUE
HERRIN, ILLINOIS 62946
PHONE: 618-942-6818 FAX: 618-942-6819
EMAIL: general@architecturals.com

Project number 19-985
Date 12-6-19
Drawn by CLO
Checked by SBS

LS-2.0

Scale As indicated