


SITE PLAN LEGEND

- W — W — DOMESTIC WATER LINE
- UE — UE — UNDERGROUND ELECTRICAL LINE
- SAN — SAN — SANITARY SEWER LINE
- OE — OE — OVERHEAD UTILITY LINE
- G — G — GAS LINE
- x — x — 4 FOOT HIGH CHAIN LINK FENCE




1 SAFETY REFERENCE SITE PLAN
1" = 60'-0"


ARCHITECHNIQUES
 LIMITED
817 SOUTH PARK AVENUE
 HERRIN, ILLINOIS 62948
 phone: 618-942-8918 fax: 618-942-8819
 email: general@architechniquesllc.com

HERRIN CUSD #4

NORTHSIDE ATTENDANCE CNTR.

LIFE SAFETY - SITE PLAN	
Project number	19-985
Date	12/4/19
Drawn by	Author
Checked by	Checker
LSP-1.0	
Scale As indicated	

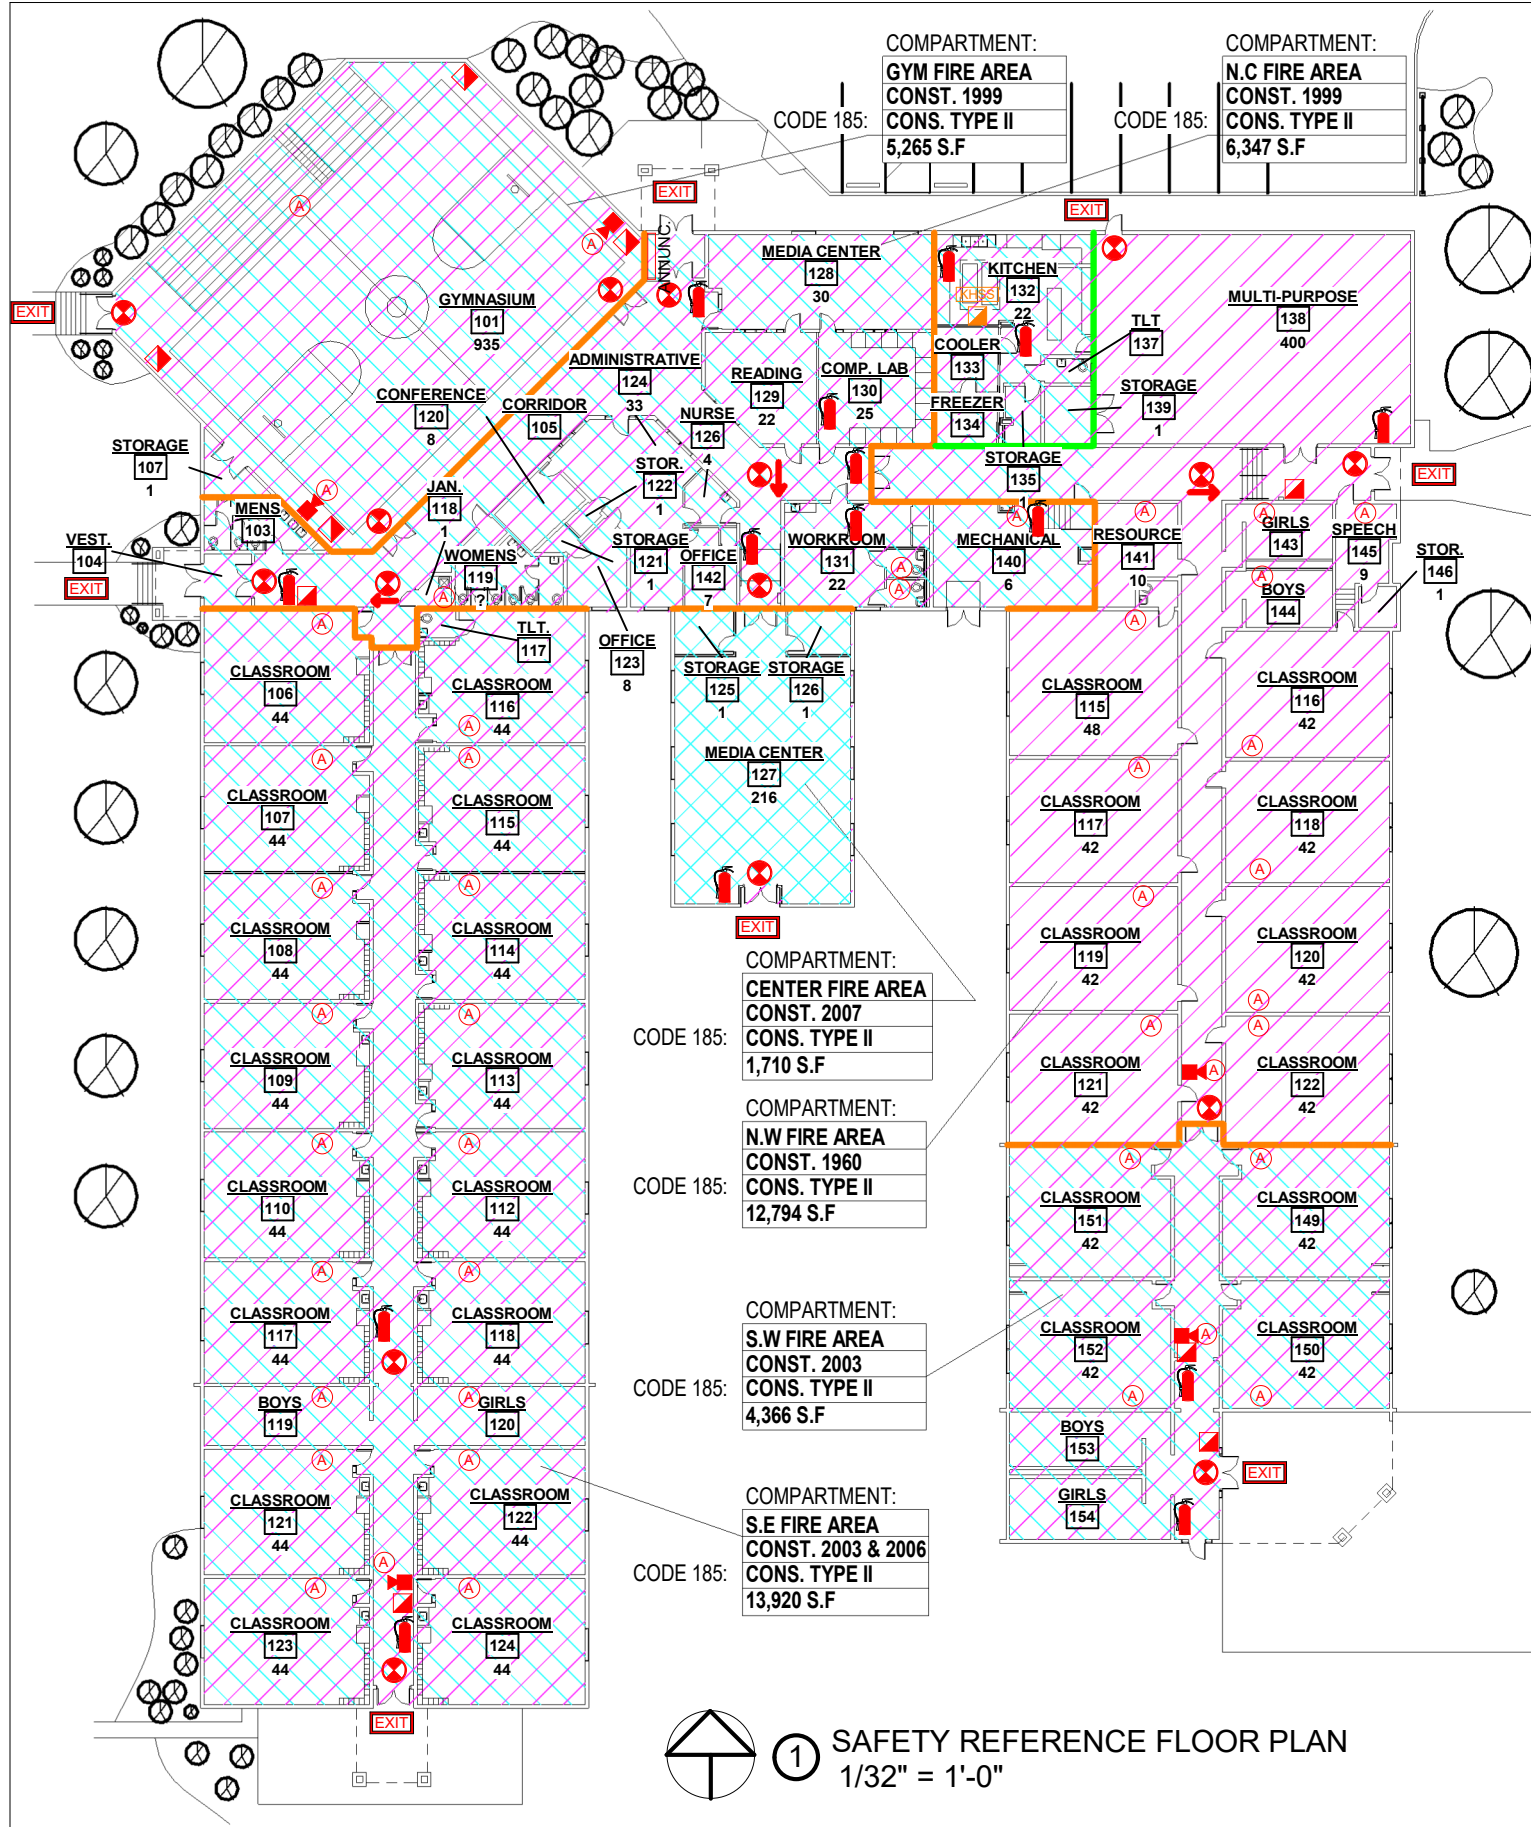

① SAFETY REFERENCE FLOOR PLAN
1/32" = 1'-0"

LIFE SAFETY PLAN KEY

- AREAS**
- SPRINKLED AREA
 - HAZARDOUS AREA
 - AREA PROTECTED BY FIRE DETECTION SYSTEM
 - EXIT STAIR
- BARRIERS**
- 1 HOUR FIRE RATED BARRIER
 - 2 HOUR FIRE RATED BARRIER
 - 3 HOUR RATED FIRE BARRIER
 - NON-RATED SMOKE LIMITING BARRIER (CORRIDOR WALL)
 - NON-RATED SMOKE BARRIER
 - COMBINATION 1/2 HOUR RATED FIRE BARRIER & SMOKE BARRIER
 - COMBINATION 1 HOUR RATED FIRE BARRIER & SMOKE BARRIER
 - COMBINATION 2 HOUR RATED FIRE BARRIER & SMOKE BARRIER
 - COMBINATION 3 HOUR RATED FIRE BARRIER & SMOKE BARRIER
- SYMBOLS**
- PATH OF MEANS OF EGRESS
 - EXIT DISCHARGE
 - EXIT SIGN
 - FIRE EXTINGUISHER
 - PULL STATION
 - DETECTOR
 - ALARM/STROBE
 - FIRE ALARM HORN
 - EMERGENCY LIGHT
 - FIRE ALARM CONTROL PANEL
 - FIRE ALARM ANNUNCIATOR PANEL
 - ELECTRICAL PANEL
 - SPRINKLER SHUTOFF VALVE
 - KITCHEN HOOD SUPPRESSION SYSTEM
 - KITCHEN SYSTEM PULL STATION

LIFE SAFETY - FLOOR PLAN

HERRIN CUSD #4



817 SOUTH PARK AVENUE
HERRIN, ILLINOIS 62948
phone: 618-942-8918 fax: 618-942-8919
email: general@architechniquesllc.com

Project number 19-985
Date 12/4/19
Drawn by SBS
Checked by SBS

NORTHSIDE ATTENDANCE CNTR.

Scale As indicated