

COVERED
STAIR WAY,
DOORS AT
TOP

General Notes

1. THE CAMPUS IS OCCUPIED AND IS BEING USED FOR ITS INTENDED PURPOSE DURING CONSTRUCTION. THE CONTRACTOR SHALL ANTICIPATE ON-SITE COORDINATION PRIOR, DURING, AND AFTER CONSTRUCTION WITH THE BUILDING STAFF.
2. ANY CHANGES OR MODIFICATIONS TO THE PROJECT CONSTRUCTION SHALL BE APPROVED BY ARCHITECT PRIOR TO WORK BEING DONE.
3. THE CONTRACTORS WORK AREA IS LIMITED TO THE IMMEDIATE AREA OF CONSTRUCTION. STAGING AREAS SHALL BE DEFINED BY THE CM/GC. ADJACENT STUDENT OCCUPIED AREAS SHALL NOT BE UTILIZED OR USED FOR STAGING OR STORAGE.
4. NOT USED
5. FOR ELECTRICAL SITE WORK SEE ELECTRICAL SITE PLAN SHEETS.

Site Notes


1. LONGITUDINAL CROSS SLOPE OF ALL SIDEWALKS SHALL NOT EXCEED 5%. HORIZONTAL CROSS SLOPE SHALL NOT EXCEED 2%. SLOPES WITH PEDESTRIAN RAMPS SHALL NOT EXCEED 12:1 IN ANY DIRECTION.
2. SLOPE WITHIN ADA ACCESSIBLE PARKING AREAS SHALL NOT EXCEED 2% IN ANY DIRECTION.
3. HORIZONTAL LAY LENGTHS OF MAINLINES & SERVICES ARE SHOWN FOR REFERENCE ONLY AND MAY VARY FROM ACTUAL INSTALLED LENGTH.
4. NOTE: DEMOLITION SHOWN IS PRESCRIPTIVE IN NATURE - IT SHALL BE THE RESPONSIBILITY OF THE CONTRACTOR TO PERFORM ALL REQUIRED SITE DEMOLITION TO ACCOMPLISH THE COMPLETED NEW OR REMODELED CONDITION SHOWN ON THE PROJECT DOCUMENTS.

Reference Notes

Applicable to this Sheet Only


NOTE: demolition shown is prescriptive in nature - it shall be the Responsibility of the contractor to perform all required site demolition to accomplish the completed new or remodeled condition shown on the project documents.

- | | |
|-----------------------|------------------|
| EXISTING & DEMOLITION | NEW & RENNOVATED |
| 1 | A |

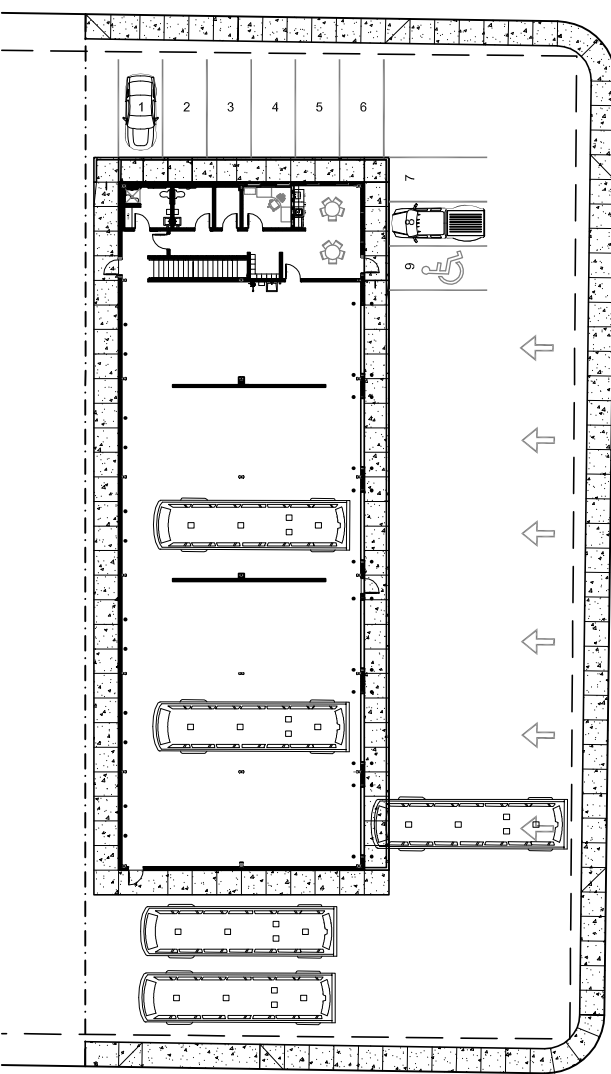

1 Campus Site Plan - Overall
SCALE: 1:40

2 Bus Barn Site Plan
SCALE: 1:40

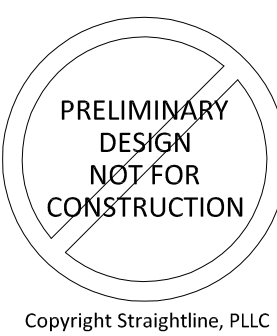

DUFUR SCHOOL DISTRICT #29

CLASSROOM BUILDING ADDITION & REMODEL

DUFUR RANGERS

STRAIGHTLINE
ARCHITECTURE

4521 South Cloverdale Road,
Suite 102 - Boise, Idaho 83709
P: 208.991.0855
Scott@StraightlineArchitects.com

Date: 4-23-2018
Project: 1625
Drawn by: S.Marshall
T.Tran

Version History:

SCHEMATIC DESIGN

DRAWING NO.

A0.1

Campus Site Plan